


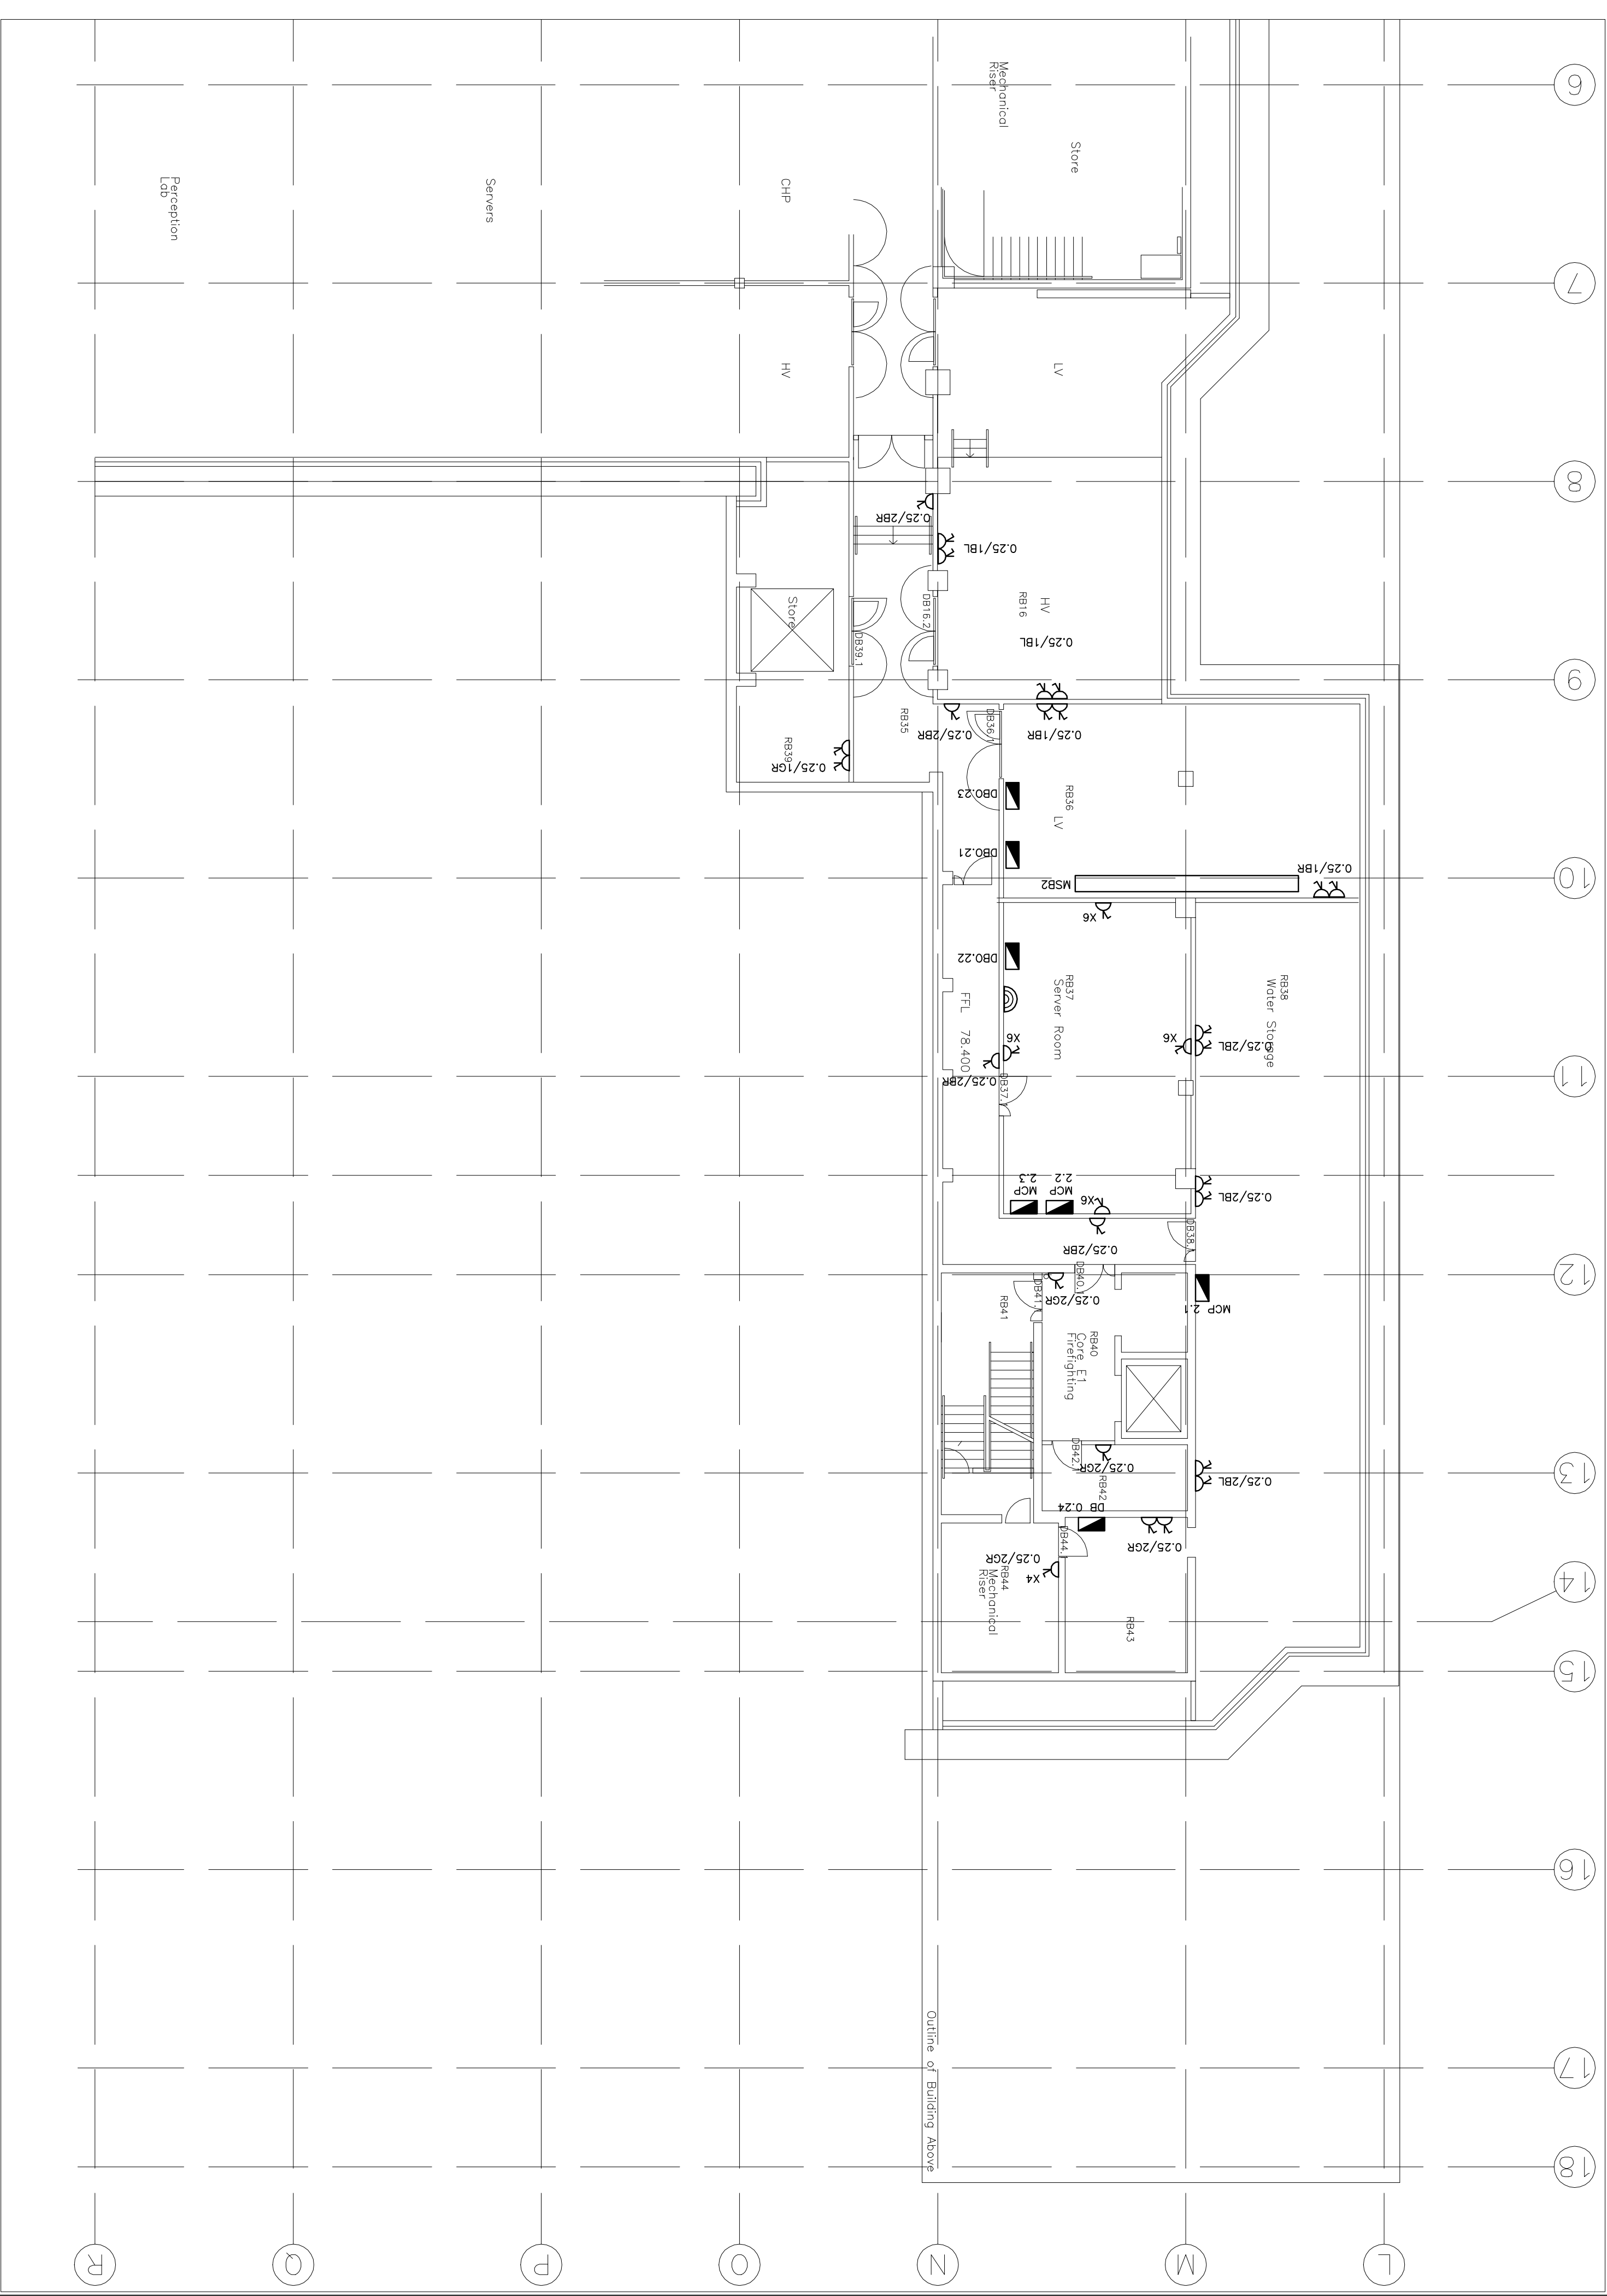

ARCHITECTBENNETTS ASSOCIATES / RELACH AND HALL
PROJECTThe University of Edinburgh - Potterrow
Phase 2A
Small Power, Data & Comms
General Arrangement Sheet 1 of 4

DATE11/04/2004
CHECKED BYTVA
DRAWN BYTVA
JOB NO.0082209
REV A

FOUR WINDS
PACIFIC QUAY
GLASGOW G61 1DY
Tel: +44 (0)141 419 3000
Fax: +44 (0)20 787 4148
Email: 00820@fourwindsppd.com
Web: www.fourwindsppd.com

CONSULTING ENGINEERS
BURO HAPPOLD

BILLING

Rev	Description	Date	By	CHKD
A	ISSUED FOR BILLING	JAN 05	REM	APF
0	ISSUED FOR WARRANT	NOV 04	REM	APF

LEGEND

 SINGLE 13A SWITCHED SOCKET

 TWIN 13A SWITCHED SOCKET

 2 No. OF SOCKET OUTLETS

 IP65 RATED SINGLE BS4343 SOCKET OUTLET

 BUSBAR TRUNKING SYSTEM

 END FEED FOR BUSBAR

 DATA AND POWER HUB WITH PLUG CONNECTION

 POWER CABLE TRAY RUN TO BUSBAR

 AT HIGH LEVEL

 DISTRIBUTION BOARD

 THREE PHASE OUTLET

 HEAVY DUTY STEEL FLOORBOX WITH STONE INSERT TO MATCH FLOOR

 UNSWITCHED FCU

 TELEPHONE POINT

 DATA POINT

 ISOLATOR

NOTES

1. DO NOT SCALE FROM THIS DRAWING, IF IN DOUBT, REQUEST FURTHER INFORMATION.

2. THIS DRAWING SHALL BE READ IN CONJUNCTION WITH THE MAIN CONTRACT CONDITIONS, THE BUILDING SERVICES SPECIFICATIONS AND SCHEDULES, THE ARCHITECTS AND STRUCTURAL ENGINEERS DRAWINGS.

3. REFER TO THE ARCHITECTS DRAWINGS FOR DETAILS OF ALL SETTING OUT INFORMATION, NO DIMENSIONS SHALL BE MEASURED FROM THIS DRAWING.

4. REFER TO THE ARCHITECTS REFLECTED CEILING PLANS FOR THE SETTING OUT OF ALL SOFT MOUNTED SERVICES COMPONENTS.

5. REFER TO THE ARCHITECTS DRAWINGS FOR DETAILS OF ALL BUILDING COMPARTMENTATION, ALL SERVICES SHALL BE FIRE SEALED USING THE APPROVED PENETRATION DETAIL, FULLY IN ACCORDANCE WITH THE COMPARTMENT RATINGS.