


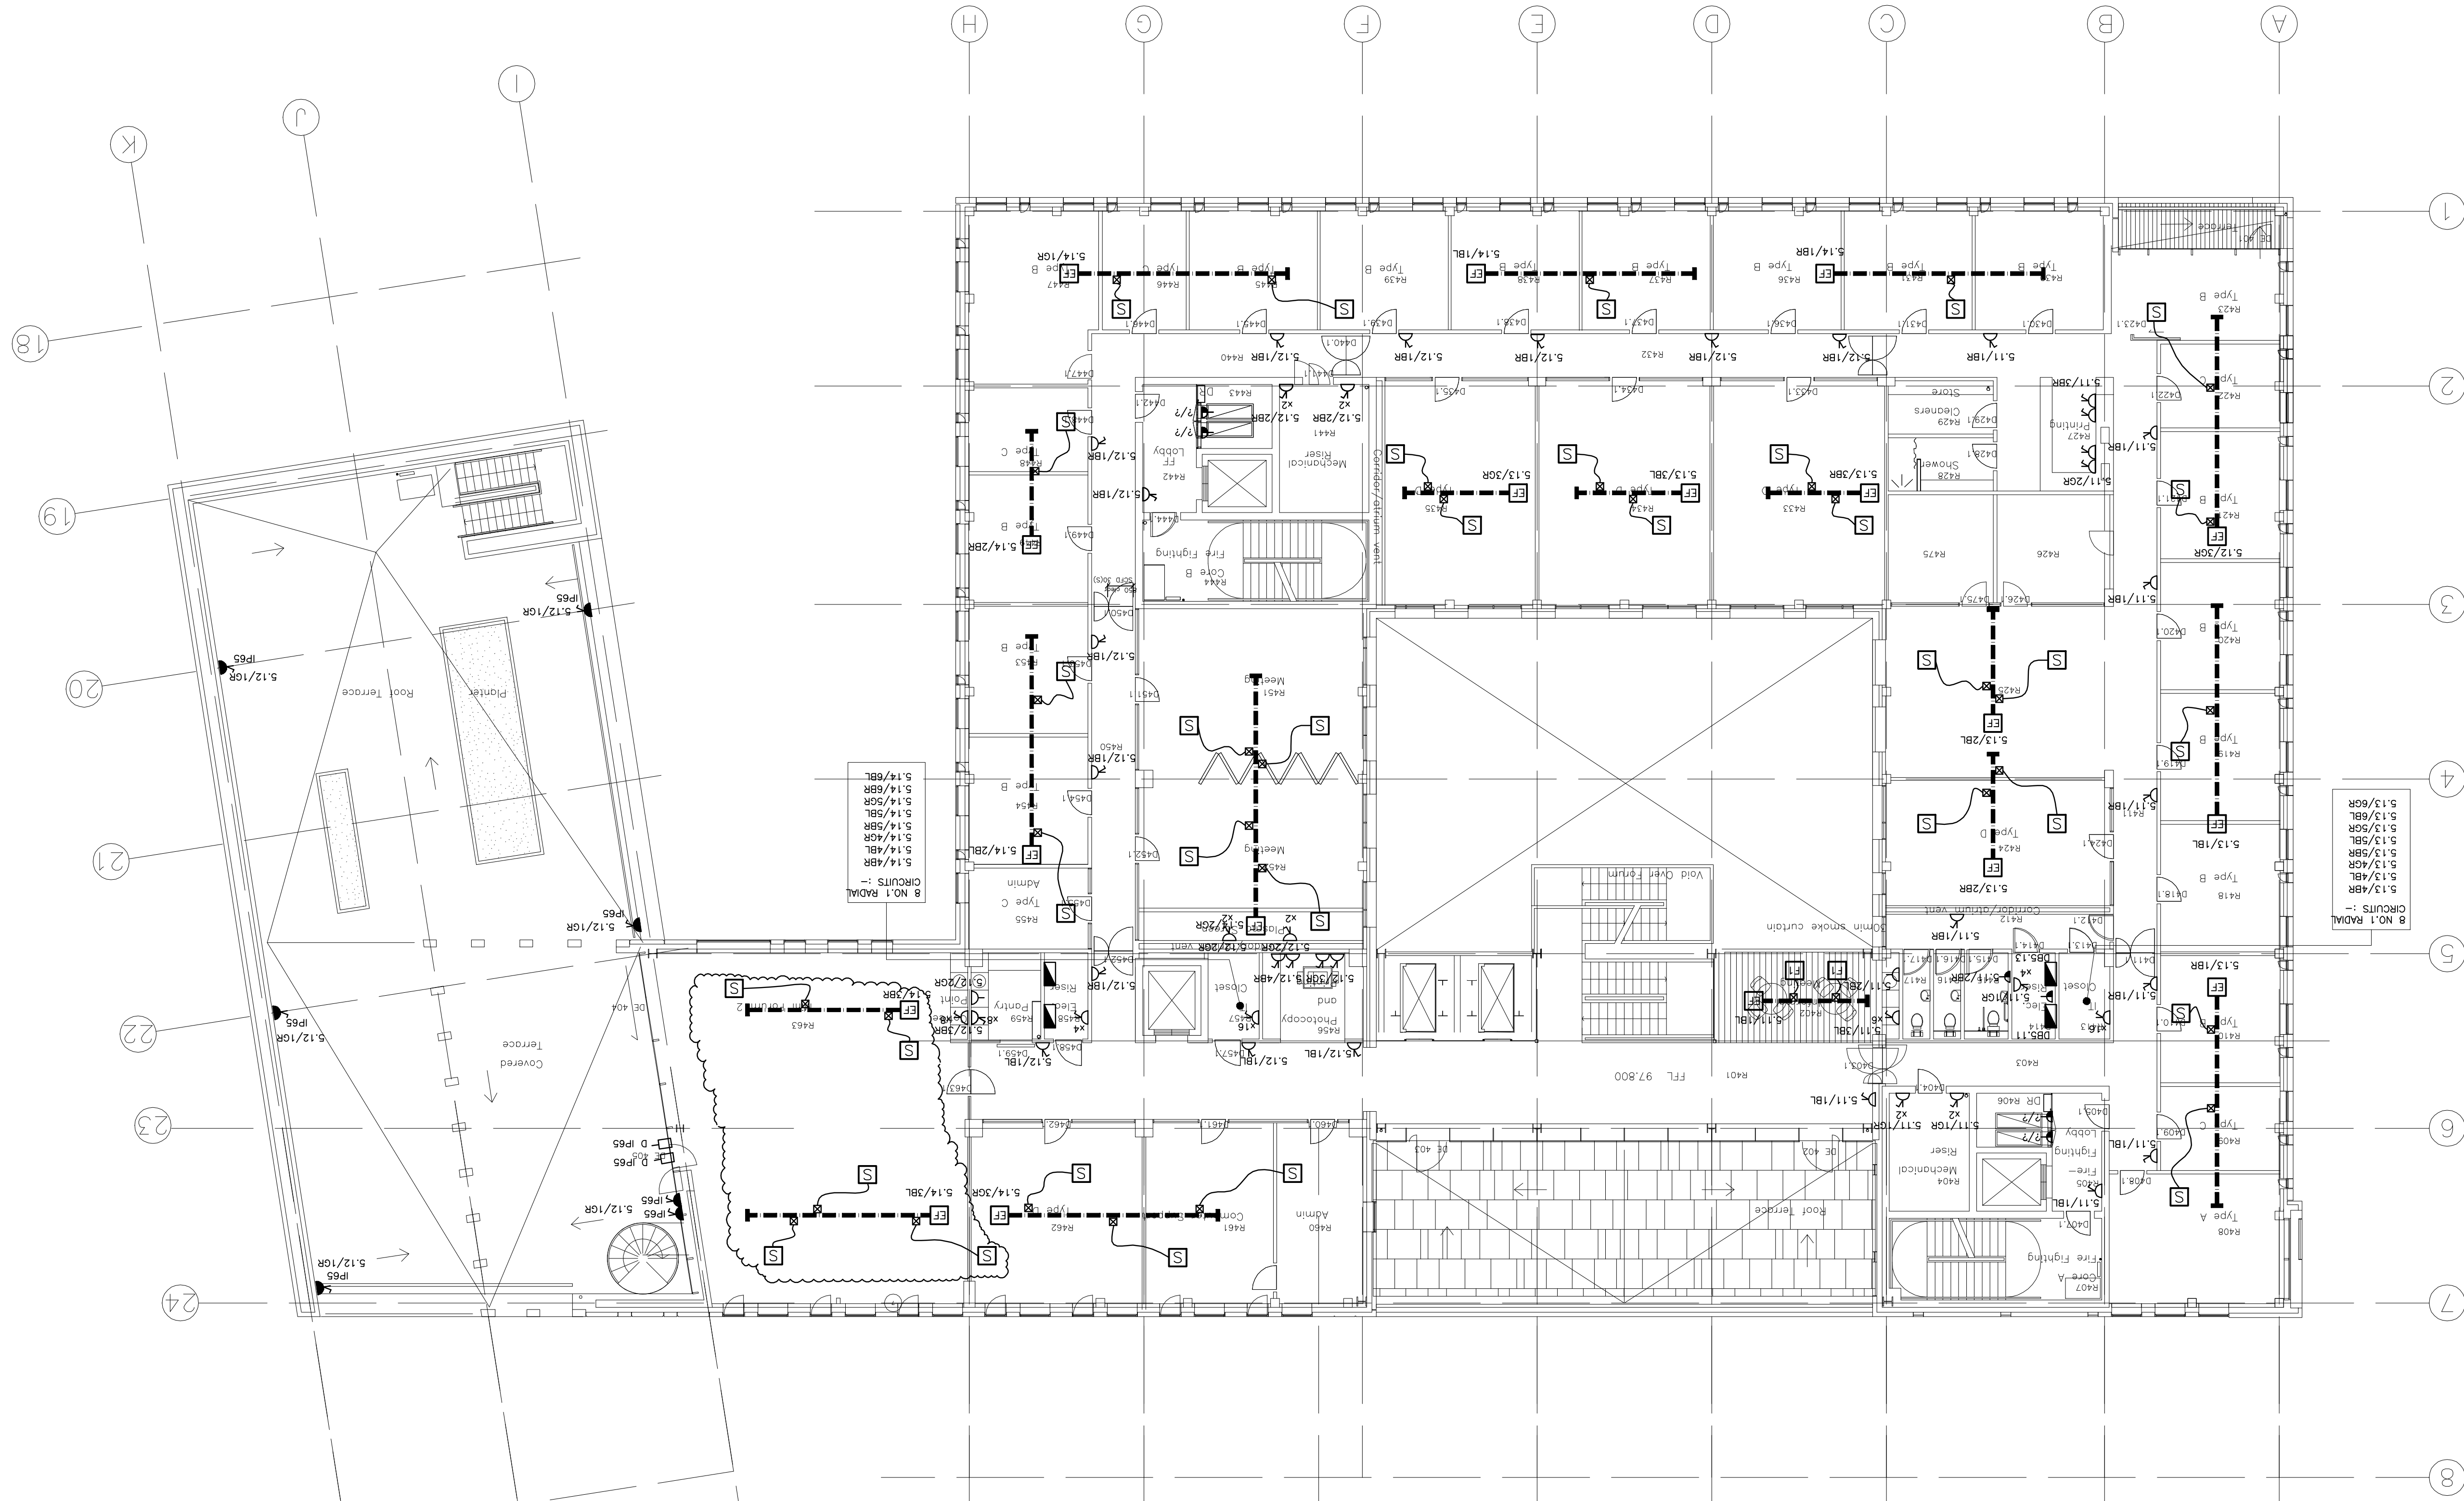

Buro Happold
Consulting Engineers
Four Winds
Pacific Quay
Glasgow G61 1DY
Tel: +44 (0)141 419 3000
Fax: +44 (0)20 787 4148
Email: 00820@burohappold.com
Web: www.burohappold.com

Architect Bennetts Associates / Reach and Hall
Project The University of Edinburgh - Potterrow
Fourth Floor - Phase 1
Small Power, Data & Comms
General Arrangement

Job No. 0082209
Drawing No. E 151
Rev A
Date November 2004

BILLING

Rev	Description	Date	By	Check
0	ISSUED FOR BILLING	NOV 04	REM	APF
1	ISSUED FOR COMMENT	NOV 04	REM	APF

- LEGEND**
- SINGLE 13A SWITCHED SOCKET
 - TWIN 13A SWITCHED SOCKET
 - '2' No. OF SOCKET OUTLETS
 - IP65 RATED SINGLE BS4343 SOCKET OUTLET
 - BUSBAR TRUNKING
 - SYSTEM
 - END FEED FOR BUSBAR
 - DATA AND POWER HUB WITH PLUG CONNECTION TO BUSBAR
 - POWER CABLE TRAY RUN AT HIGH LEVEL
 - DISTRIBUTION BOARD
 - THREE PHASE OUTLET
 - HEAVY DUTY STEEL FLOORBOX WITH STONE INSERT TO MATCH FLOOR
 - UNSWITCHED FCU
 - TELEPHONE POINT
 - DATA POINT
 - ISOLATOR

- Notes**
- DO NOT SCALE THIS DRAWING.
 - THIS DRAWING SHALL BE READ IN CONJUNCTION WITH THE MAIN CONTRACT CONDITIONS, THE BUILDING SERVICES SPECIFICATIONS AND SCHEDULES, THE ARCHITECTS AND STRUCTURAL ENGINEERS DRAWINGS.
 - REFER TO THE ARCHITECTS DRAWINGS FOR DETAILS OF ALL SETTING OUT INFORMATION, NO DIMENSIONS SHALL BE MEASURED FROM THIS DRAWING.
 - REFER TO THE ARCHITECTS REFLECTED CEILING PLANS FOR THE SETTING OUT OF ALL SIGHT MOUNTED SERVICES COMPONENTS.
 - REFER TO THE ARCHITECTS DRAWINGS FOR DETAILS OF ALL BUILDING COMPARTMENTATION. ALL SERVICES SHALL BE FIRE SEALED USING THE APPROVED PENETRATION DETAIL, FULLY IN ACCORDANCE WITH THE COMPARTMENT RATING.