


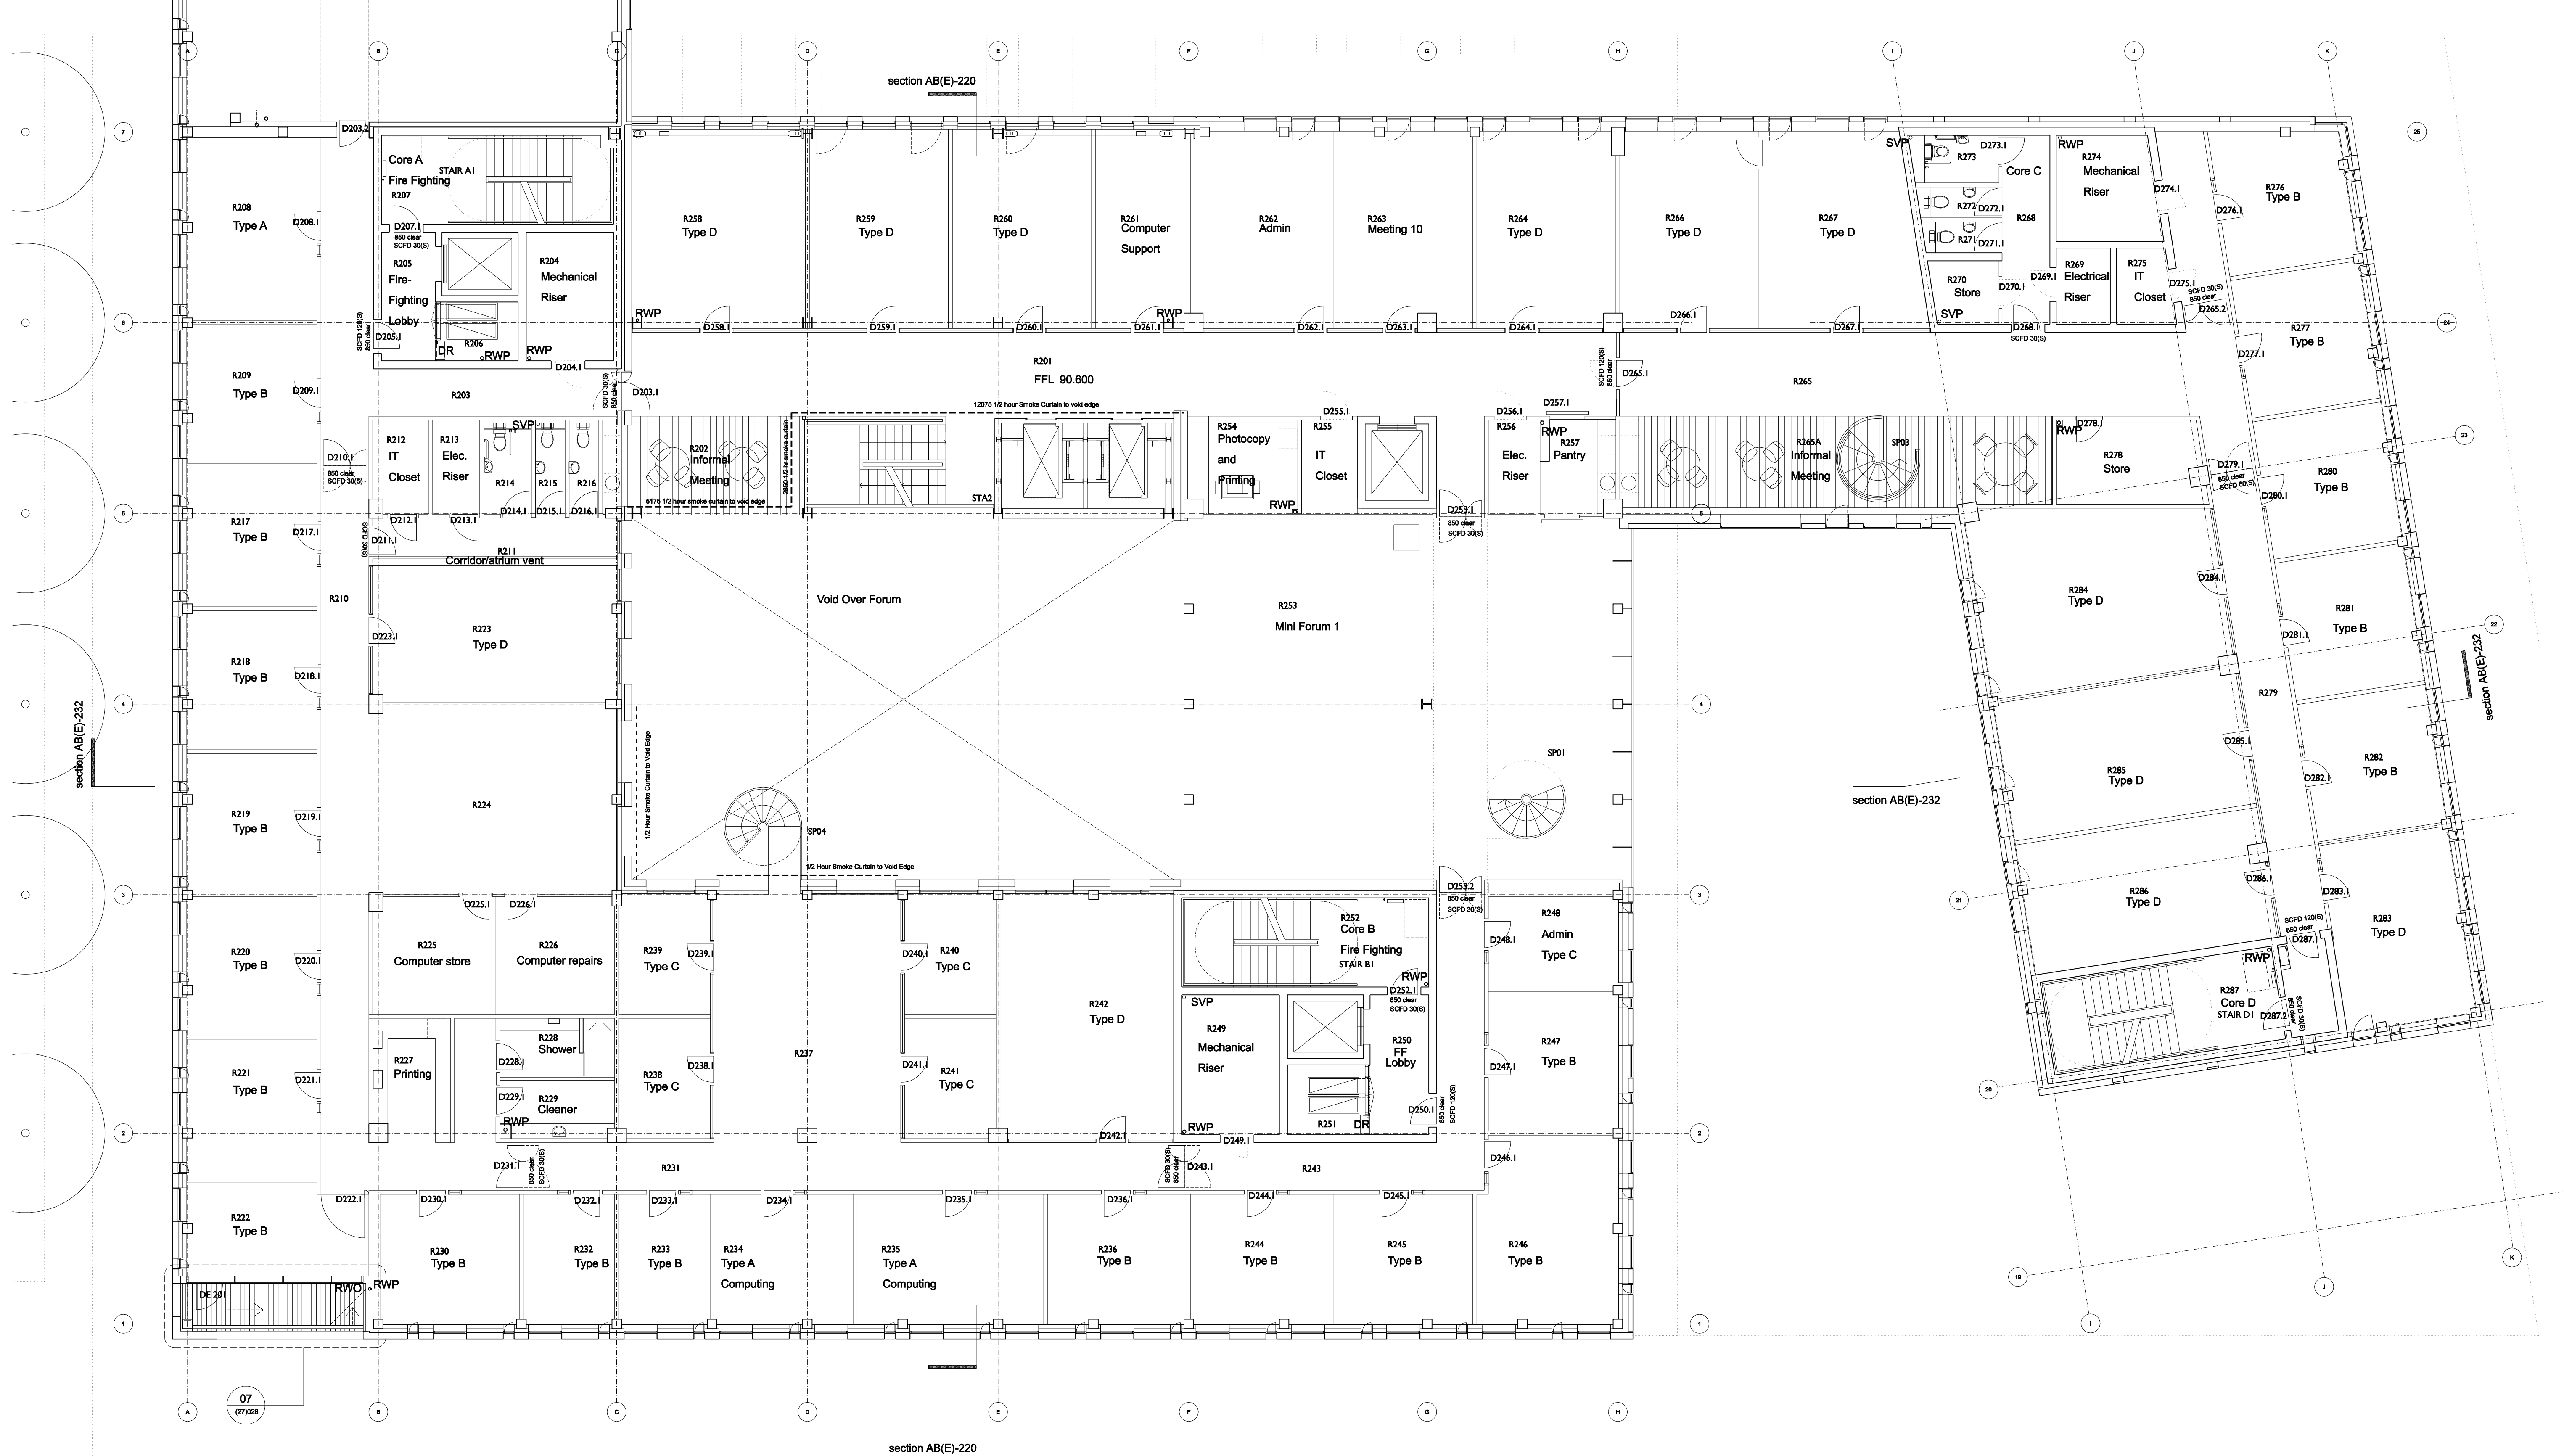

FFL 90.600

Revisions

Issued 13.10.04
A- 19.11.04
B- 26.11.04
C- 06.01.05
D- 18.02.05
E- 18.03.05

Notes

- C- Meeting room reconfigured (grd)
Internal wall vision panels shown
First billing issue (roofing)
Roof section and detail refs added
SVPs noted at roof level
Planters revised
Internal wall vision panels showns
D- Billing issue (roofing)
Further roofing notes added
E- RWP/ SVP revisions. Tender Issue

Roofing Notes

- Direction of fall of roof membrane
RWO Rainwater outlet
RWP Rainwater downpipe
OF Rainwater overflow
SVP Soil vent pipe

----- 120 minute fire curtain

----- 30 minute fire curtain

**Bennetts Associates
with
Reiach and Hall
Architects**

Bennetts Associates Architects

- 54 Manor Place Edinburgh EH3 7EH
Tel: +44 (0)131 225 9554
Fax: +44 (0)131 225 9379
E-mail: potterrow@bennettsassociates.com

Reiach and Hall Architects

- 6 Darnaway Street Edinburgh EH3 6BG
Tel: +44 (0)131 225 8444
Fax: +44 (0)131 225 5079
E-mail: potterrow@reichandhall.co.uk

Project

**Potterrow Development
for University of Edinburgh**

**Drawing Title
Phase 1
Second Floor Plan**

job no. 0312
drawing no. A(E)-102
revision E
status T

scale @ A3 1:200
scale @ A1 1:100
date Oct 2004