


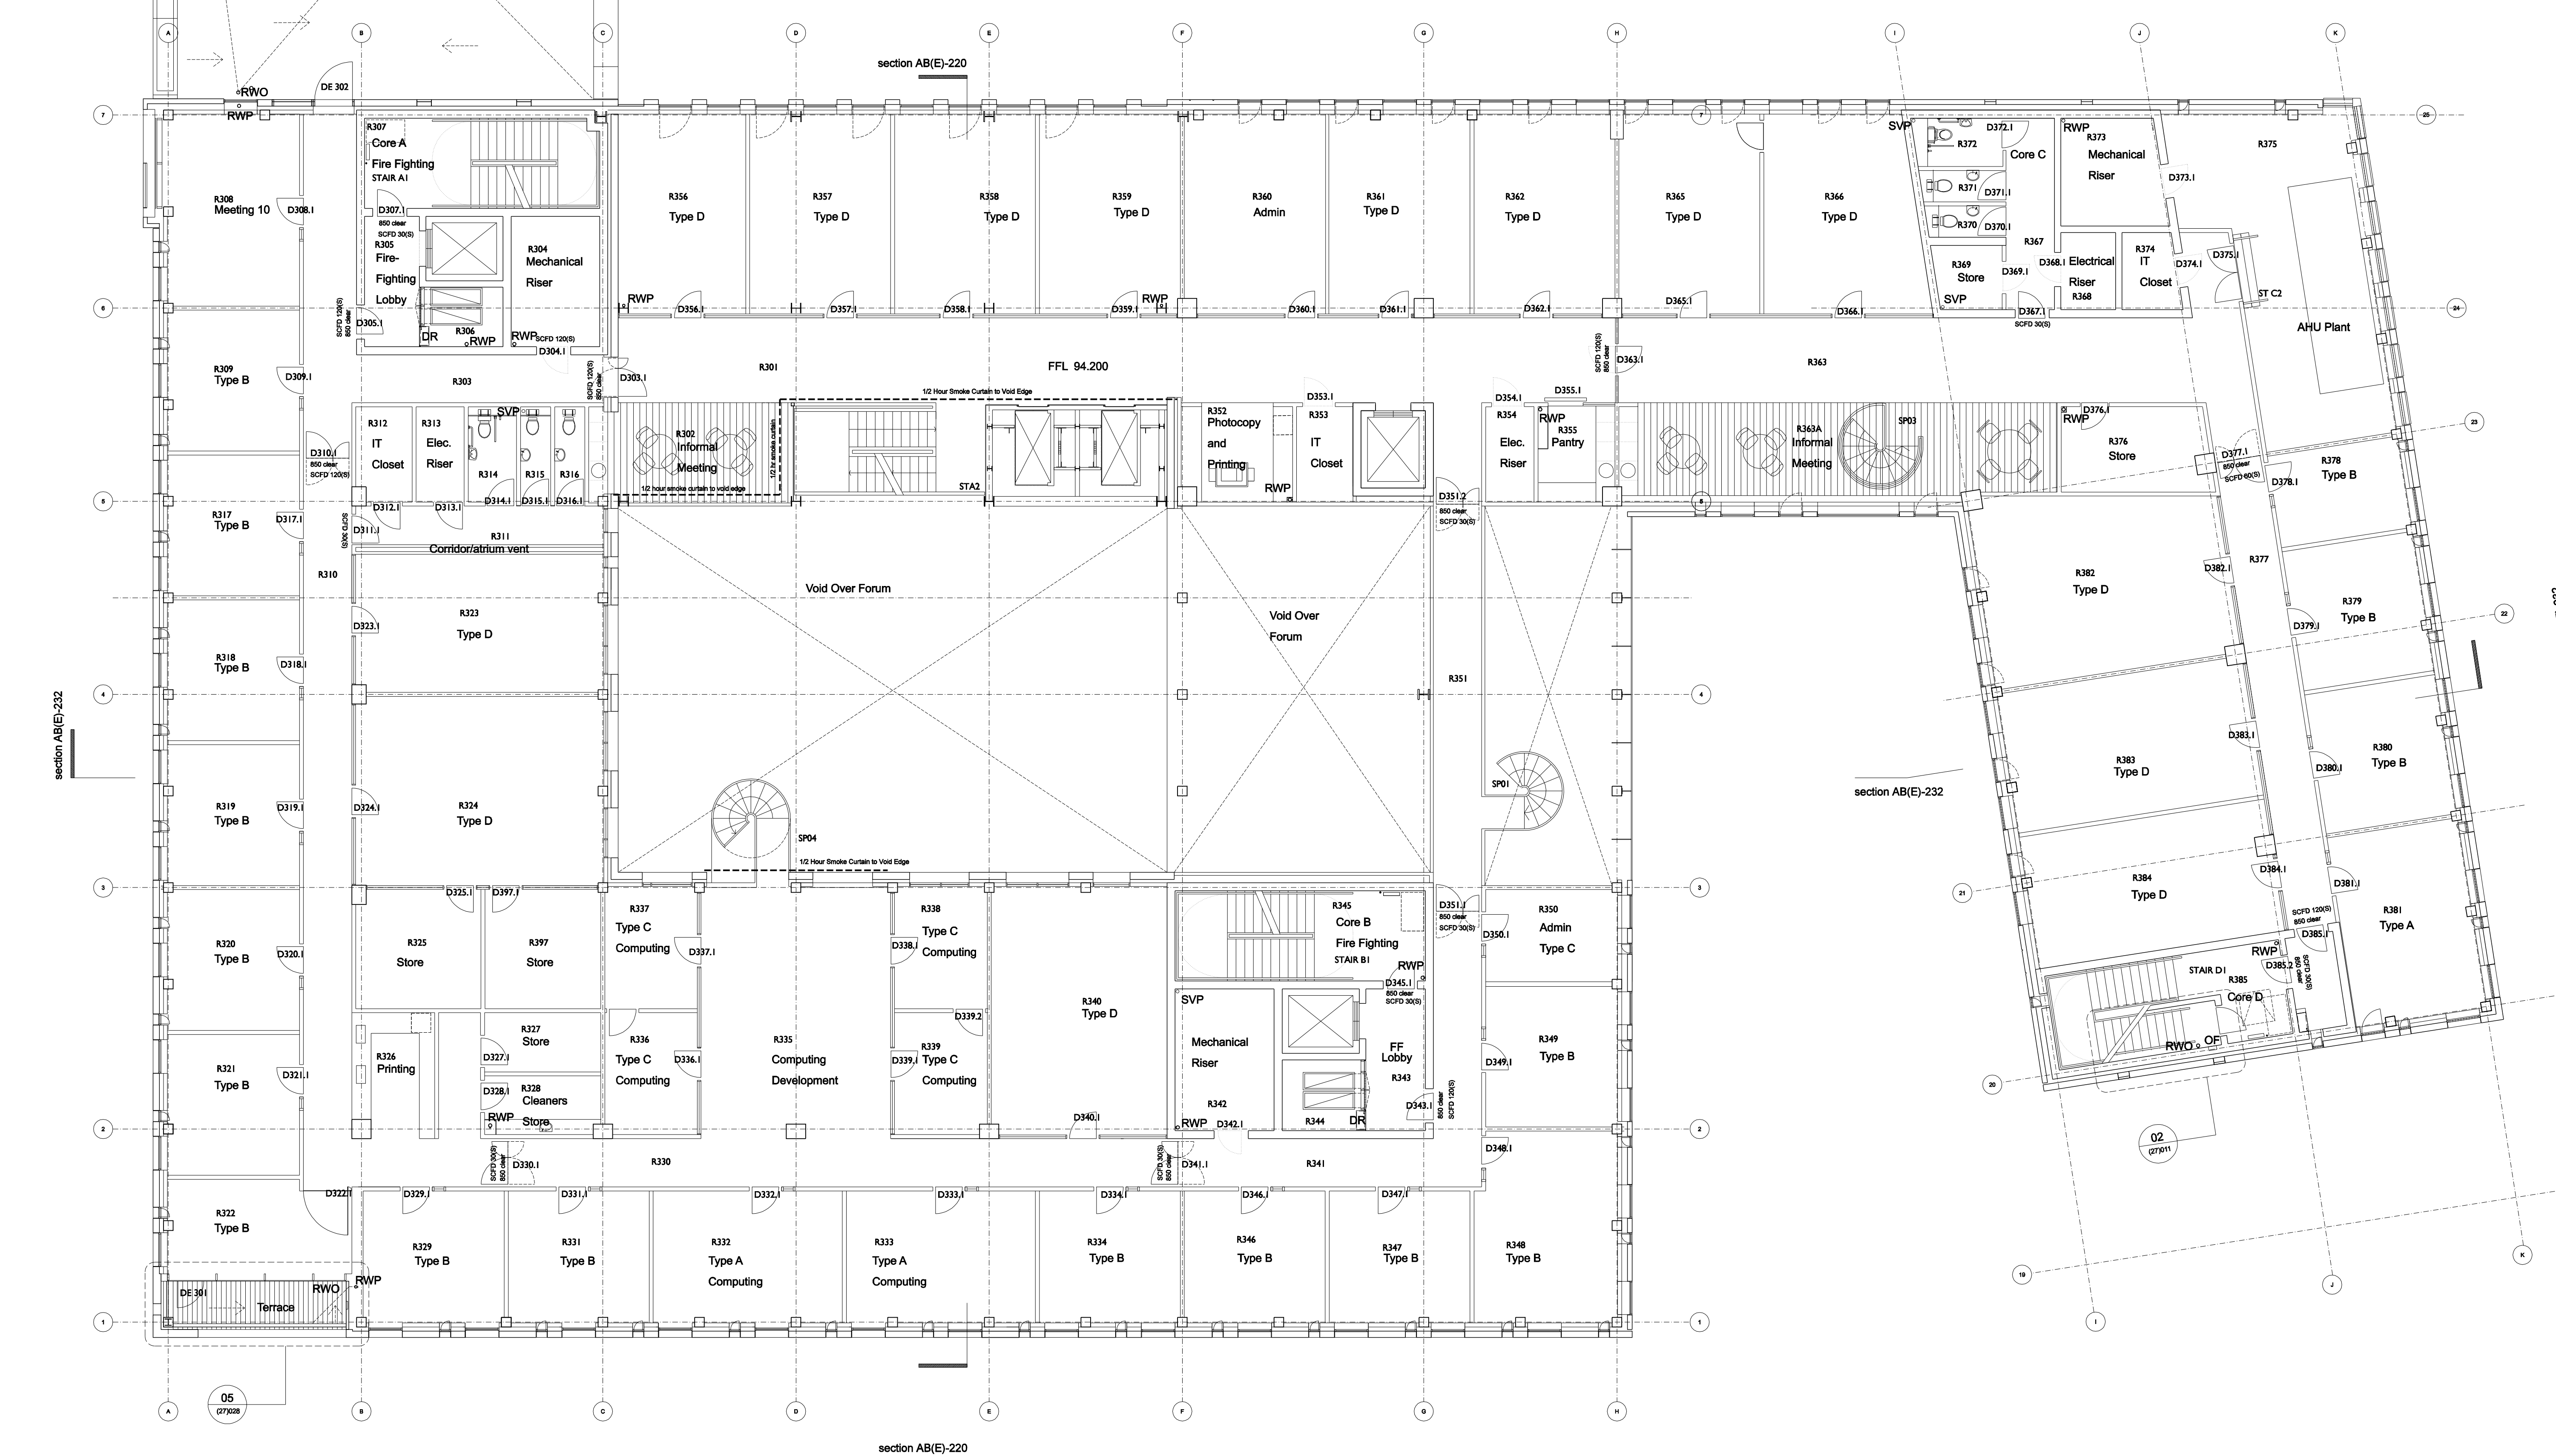

Revisions

Issued 13.10.04
A- 19.11.04
B- 20.11.04
C- 08.01.05
D- 18.02.05
E- 18.03.05

Notes

C- Meeting room reconfigured (grd)
Internal wall vision panels shown
D- Billing issue (roofing)
Further roofing notes added
E- RWP/ SVP revisions. Tender Issue

Roofing Notes

Direction of fall of roof membrane
RWO Rainwater outlet
RWP Rainwater downpipe
OF Rainwater overflow
SVP Soil vent pipe

----- 120 minute fire curtain

----- 30 minute fire curtain

**Bennetts Associates
with
Reiach and Hall
Architects**

Bennetts Associates Architects

54 Manor Place Edinburgh EH3 7EH
Tel: +44 (0)131 225 9554
Fax: +44 (0)131 225 9379
E-mail: potterrow@bennettsassociates.com

Reiach and Hall Architects

6 Darnaway Street Edinburgh EH3 6BG
Tel: +44 (0)131 225 8444
Fax: +44 (0)131 225 5079
E-mail: potterrow@reichandhall.co.uk

Project

**Potterrow Development
for University of Edinburgh**

**Drawing Title
Phase 1
Third Floor Plan**

job no.	drawing no.	revision	status
0312	A(E)-103	E	T

scale @ A3	scale @ A1	date
1:200	1:100	Oct 2004

FFL 94.200