


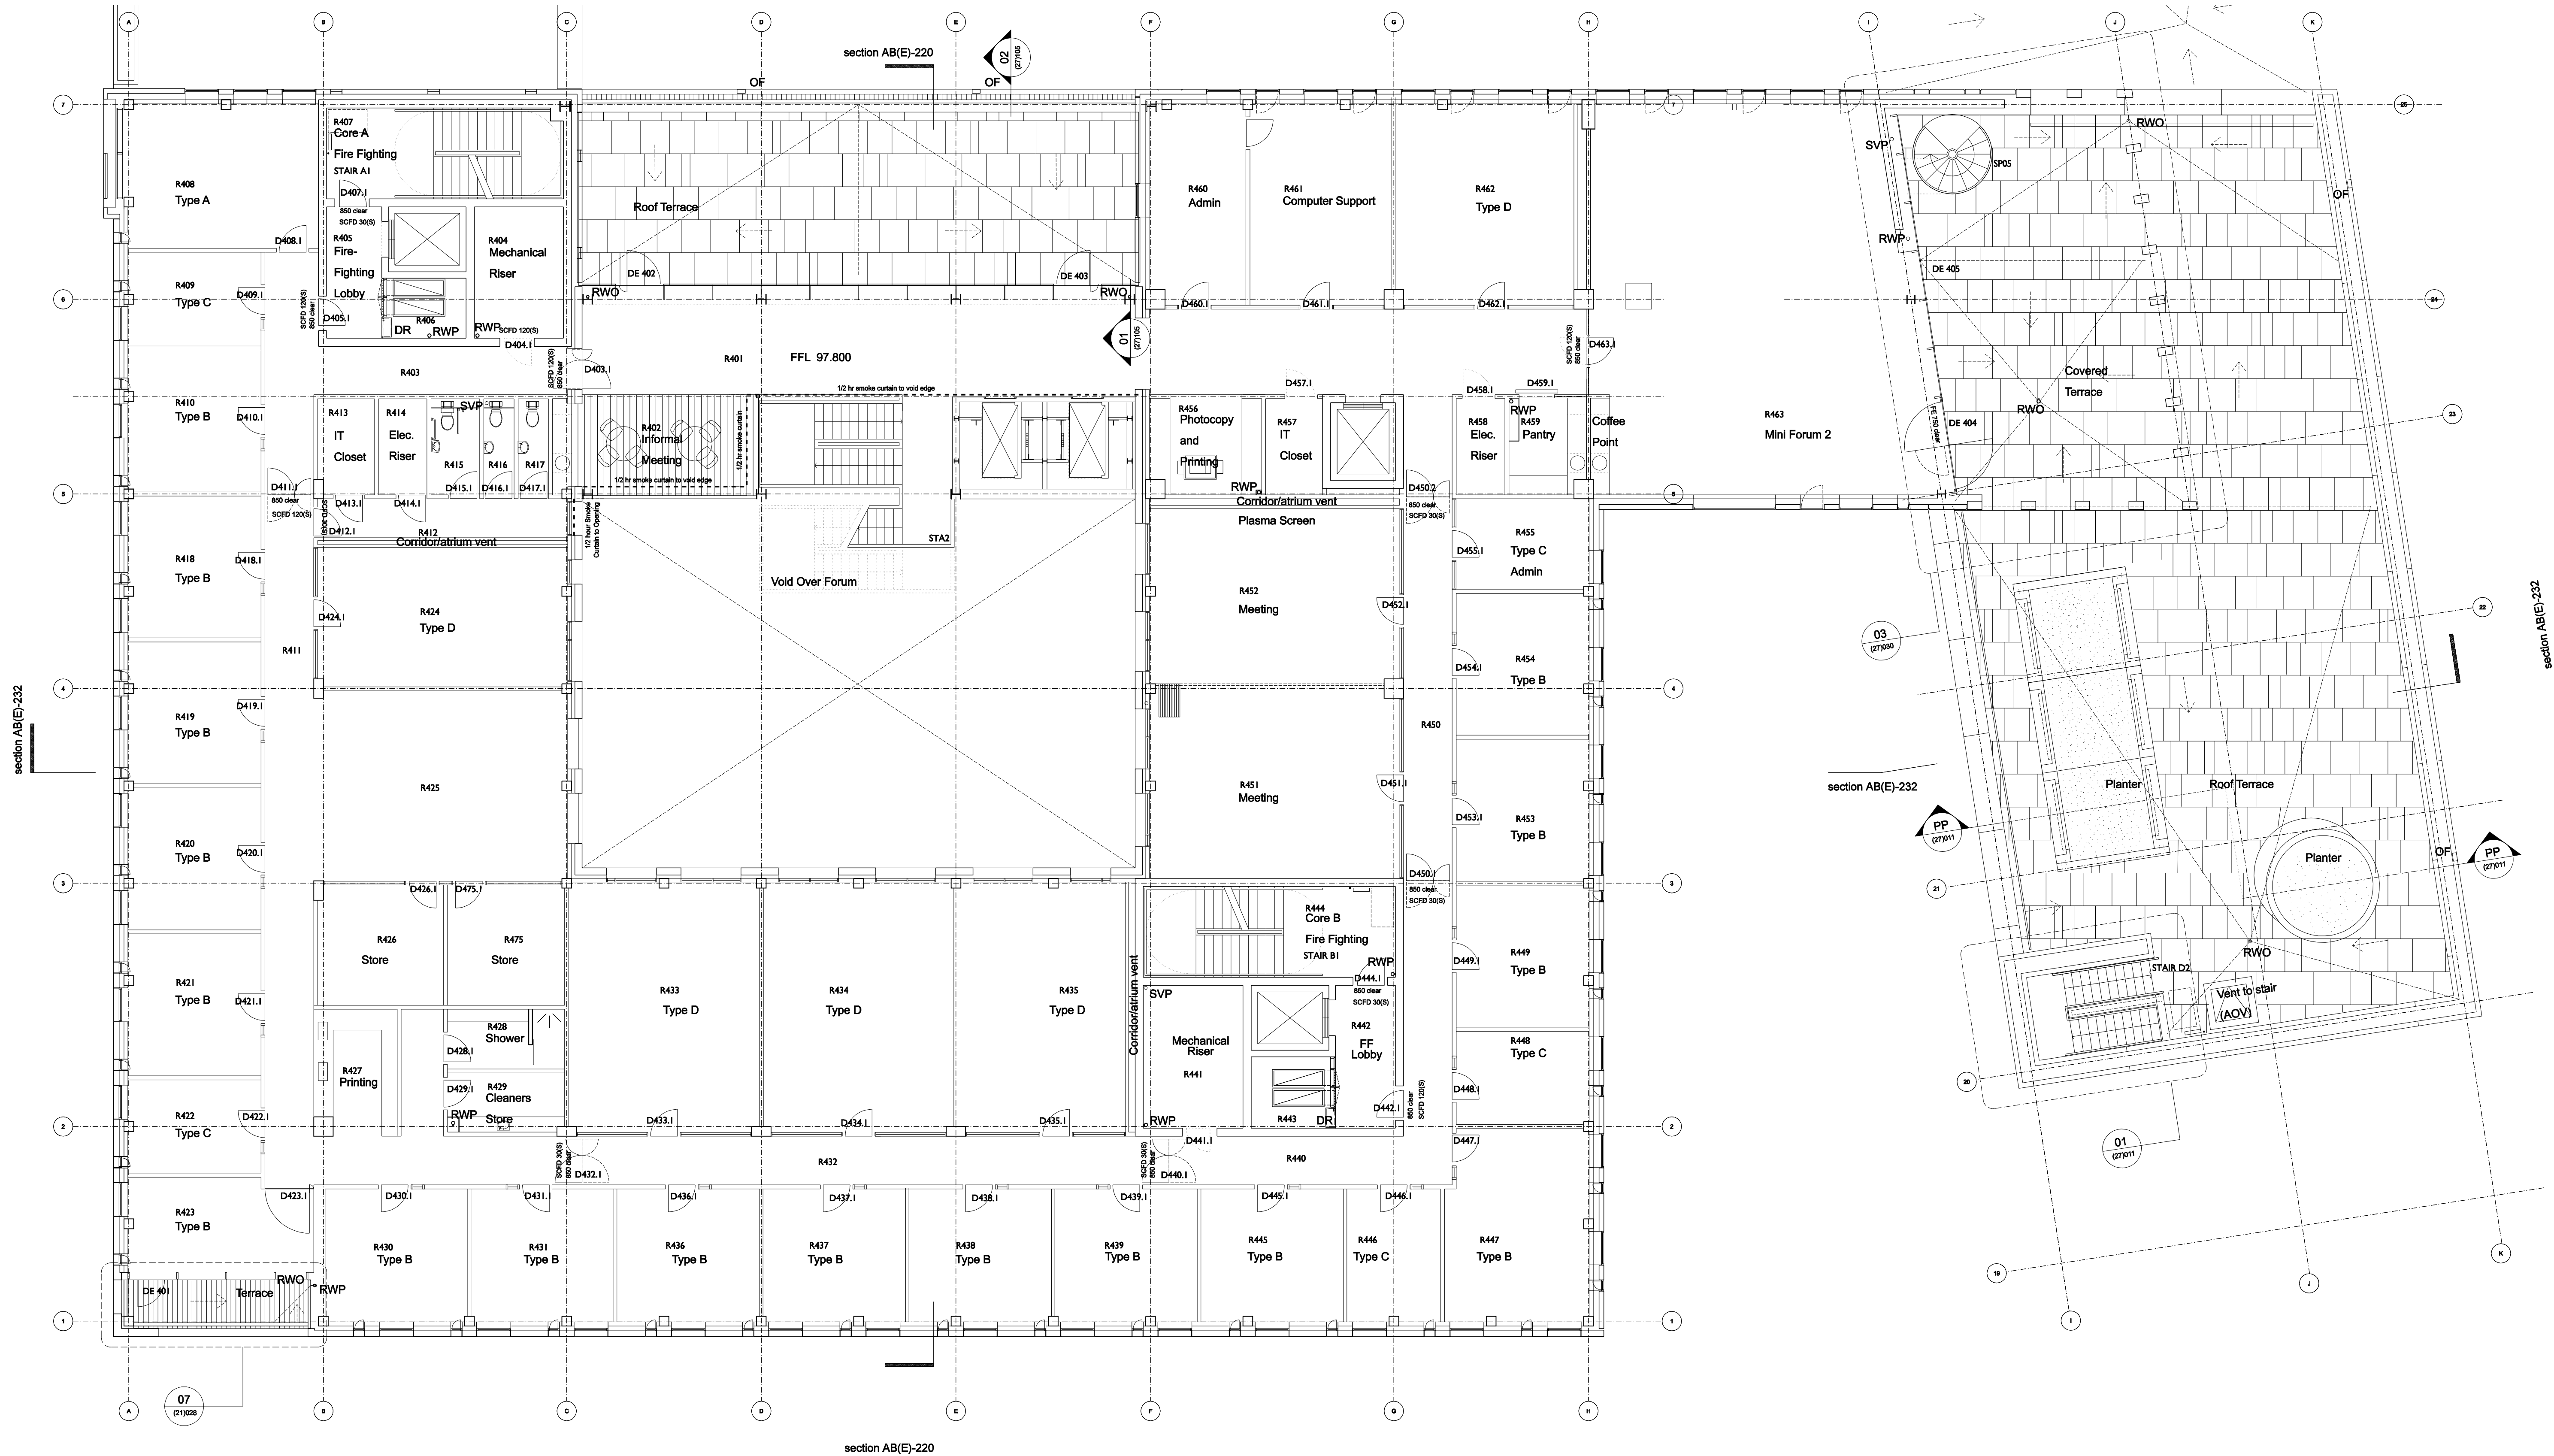

Revisions

Issued 13.10.04
A- 19.11.04
B- 26.11.04
C- 08.01.05
D- 18.02.05
E- 18.03.05

Notes

- C- First billing issue (roofing)
Roof section and detail refs added
SVPs noted at roof level
Planters revised
Internal wall vision panels shown
- D- Billing issue (roofing)
Further roofing notes added
- E- SVP/ RWP revisions. Tender issue

Roofing Notes

- Direction of fall of roof membrane
RWO Rainwater outlet (below paving on terraces)
RWP Rainwater downpipe
OF Rainwater overflow
SVP Soil vent pipe

----- 120 minute fire curtain
----- 30 minute fire curtain

Bennetts Associates with Reiach and Hall Architects

Bennetts Associates Architects

- 54 Manor Place Edinburgh EH3 7EH
Tel: +44 (0)131 225 9554
Fax: +44 (0)131 225 9379
E-mail: potterrow@bennettsassociates.com

Reiach and Hall Architects

- 6 Darnaway Street Edinburgh EH3 6BG
Tel: +44 (0)131 225 8444
Fax: +44 (0)131 225 5079
E-mail: potterrow@reichandhall.co.uk

Project

Potterrow Development
for University of Edinburgh

Drawing Title
Phase 1
Fourth Floor Plan

job no.	drawing no.	revision	status
0312	A(E)-104	E	T

scale @ A3	scale @ A1	date
1:200	1:100	Oct 2004

FFL 97.800