


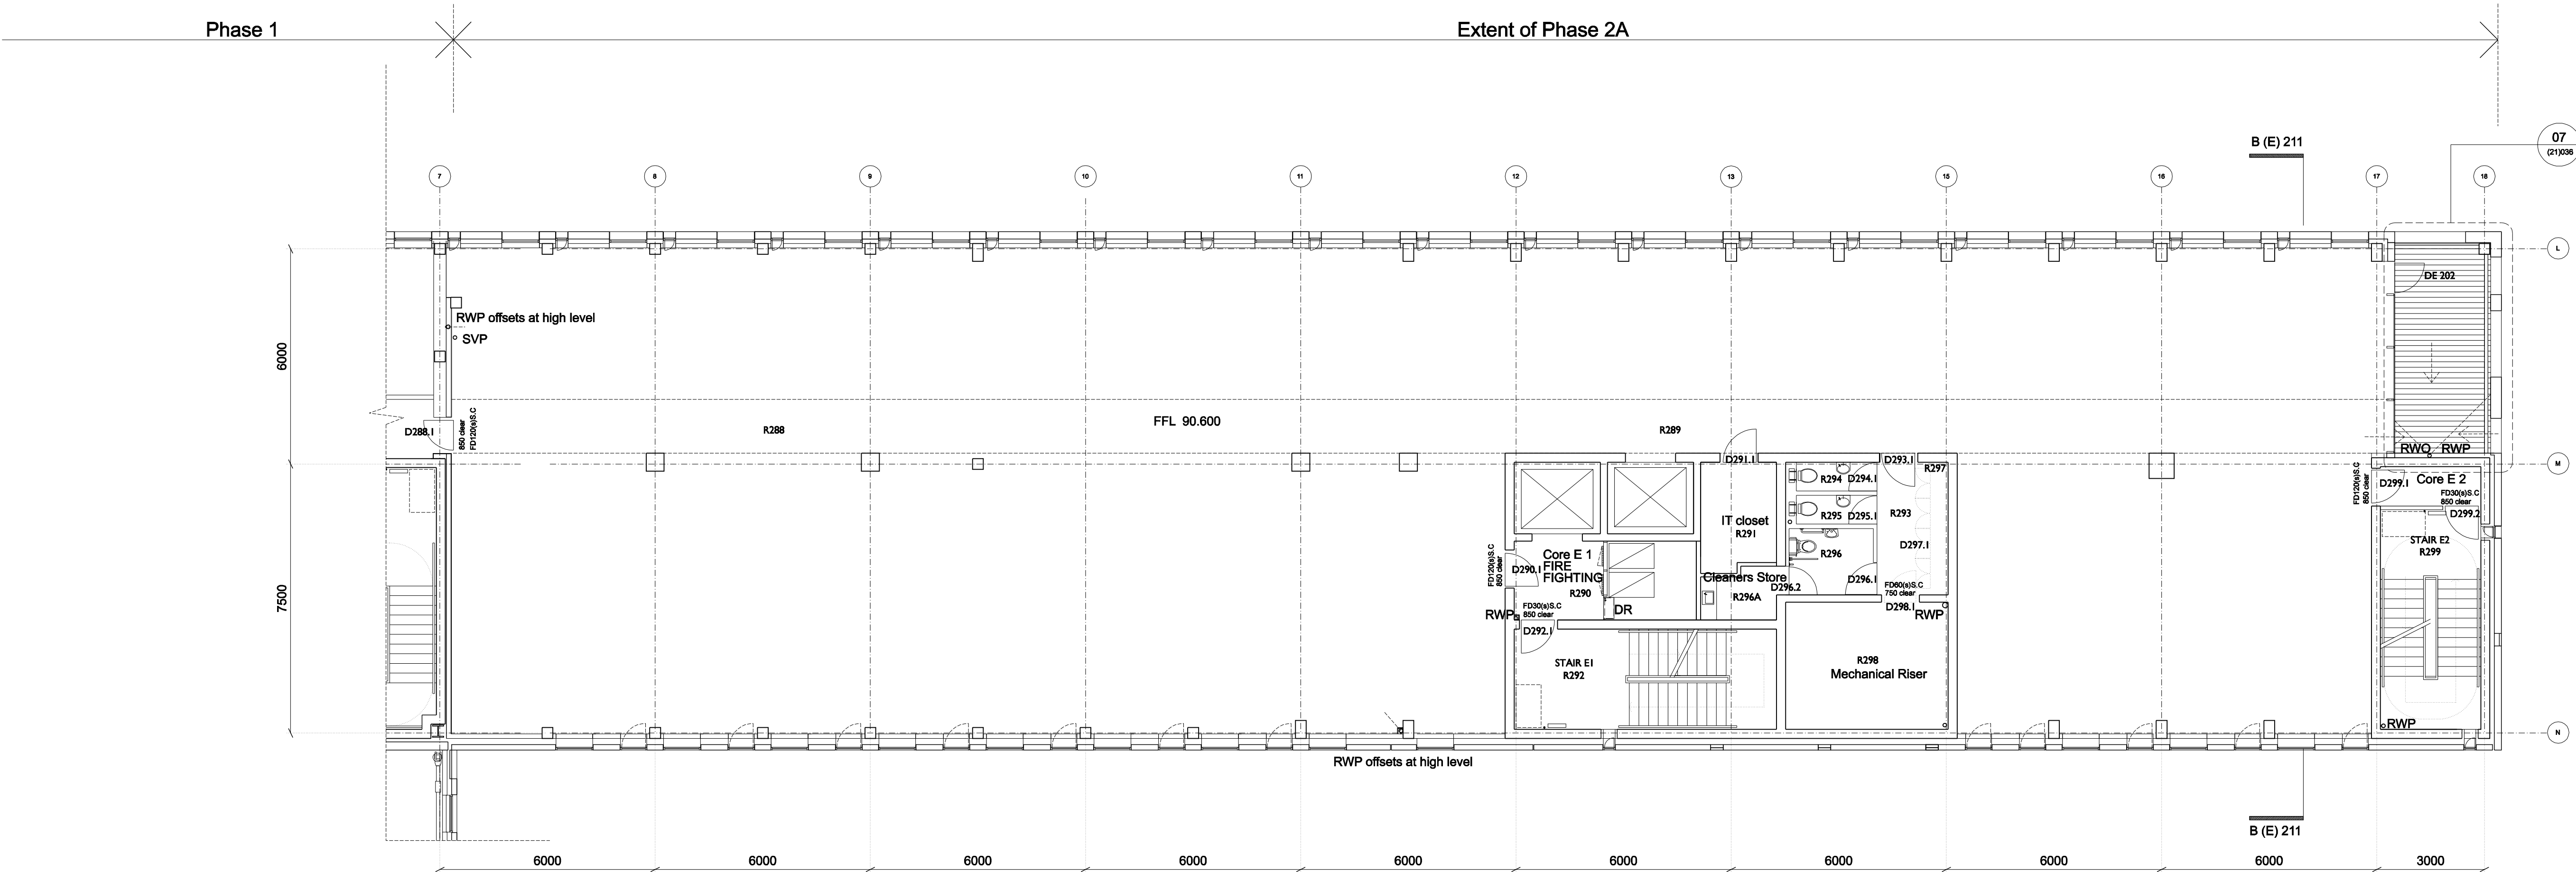

FFL 90.600

Revisions

- issued 19.11.04
A 26.11.04
B 06.01.05
C 18.02.05
D 18.03.05

Notes

B Core E1 wall grid 13 realigned
First billing issue (roofing)
Roof section and detail refs added
SVPs noted at roof level
Planters revised
Internal wall vision panels shown
C- Billing issue (roofing)
Further roofing notes added
Cleaners cupboard added to core E1
D RWP notes added. Tender Issue

Roofing Notes
Direction of fall of roof membrane
RWO Rainwater outlet
RWP Rainwater downpipe
OF Rainwater overflow
SVP Soil vent pipe

**Bennetts Associates
with
Reiach and Hall
Architects**

Bennetts Associates Architects
54 Manor Place Edinburgh EH3 7EH
Tel: +44 (0)131 225 9554
Fax: +44 (0)131 225 9379
E-mail: potterrow@bennettsassociates.com

Reiach and Hall Architects
6 Darnaway Street Edinburgh EH3 6BG
Tel: +44 (0)131 225 8444
Fax: +44 (0)131 225 5079
E-mail: potterrow@reichandhall.co.uk

Project
**Potterrow Development
for University of Edinburgh**

Drawing Title
**Phase 2A
Second Floor Plan**

job no.	drawing no.	revision	status
0312	B(E)102	D	T

scale @ A3	scale @ A1	date
1:200	1:100	Jan 05