


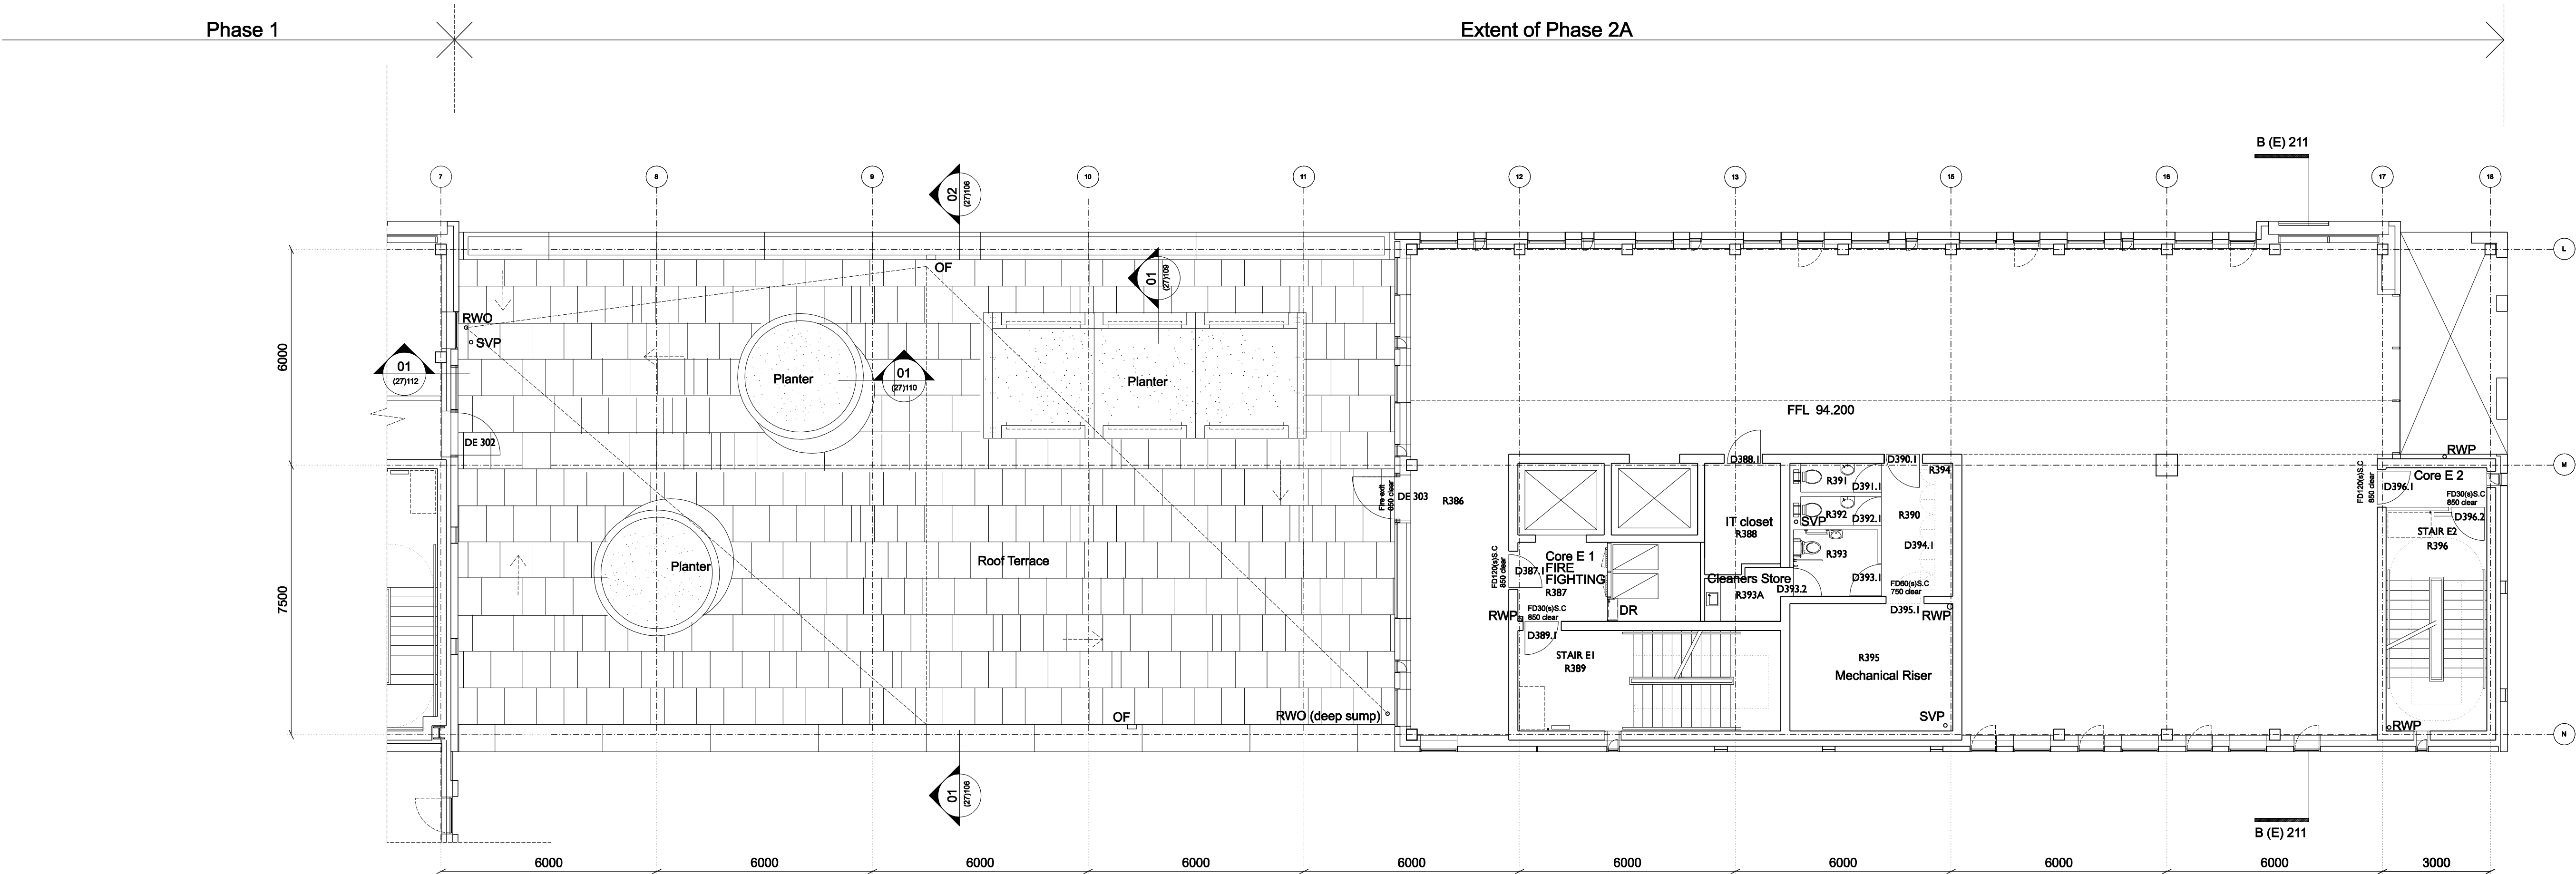

FFL 94.200

Revisions

- issued 19.11.04
A- 26.11.04
B- 06.01.05
C- 18.02.05
D- 18.03.05

Notes

B- First billing issue (roofing)
Roof section and detail refs added
SVPs noted at roof level
Planters revised
Core E1 wall grid 13 realigned
C- Billing issue (roofing)
Further roofing notes added
D- RWO outlets revised. Tender Issue

Roofing Notes

Direction of fall of roof membrane
RWO Rainwater outlet (below paving in terraced areas)
RWP Rainwater downpipe
OF Rainwater overflow
SVP Soil vent pipe

**Bennetts Associates
with
Reiach and Hall
Architects**

Bennetts Associates Architects

54 Manor Place Edinburgh EH3 7EH
Tel: +44 (0)131 225 9554
Fax: +44 (0)131 225 9379
E-mail: potterrow@bennettsassociates.com

Reiach and Hall Architects

6 Darnaway Street Edinburgh EH3 6BG
Tel: +44 (0)131 225 8444
Fax: +44 (0)131 225 5079
E-mail: potterrow@reichandhall.co.uk

Project
**Potterrow Development
for University of Edinburgh**

Drawing Title
**Phase 2A
Third Floor Plan**

job no. 0312
drawing no. B(E)103
revision D
status T

scale @ A3 1:200
scale @ A1 1:100
date Jan 05