


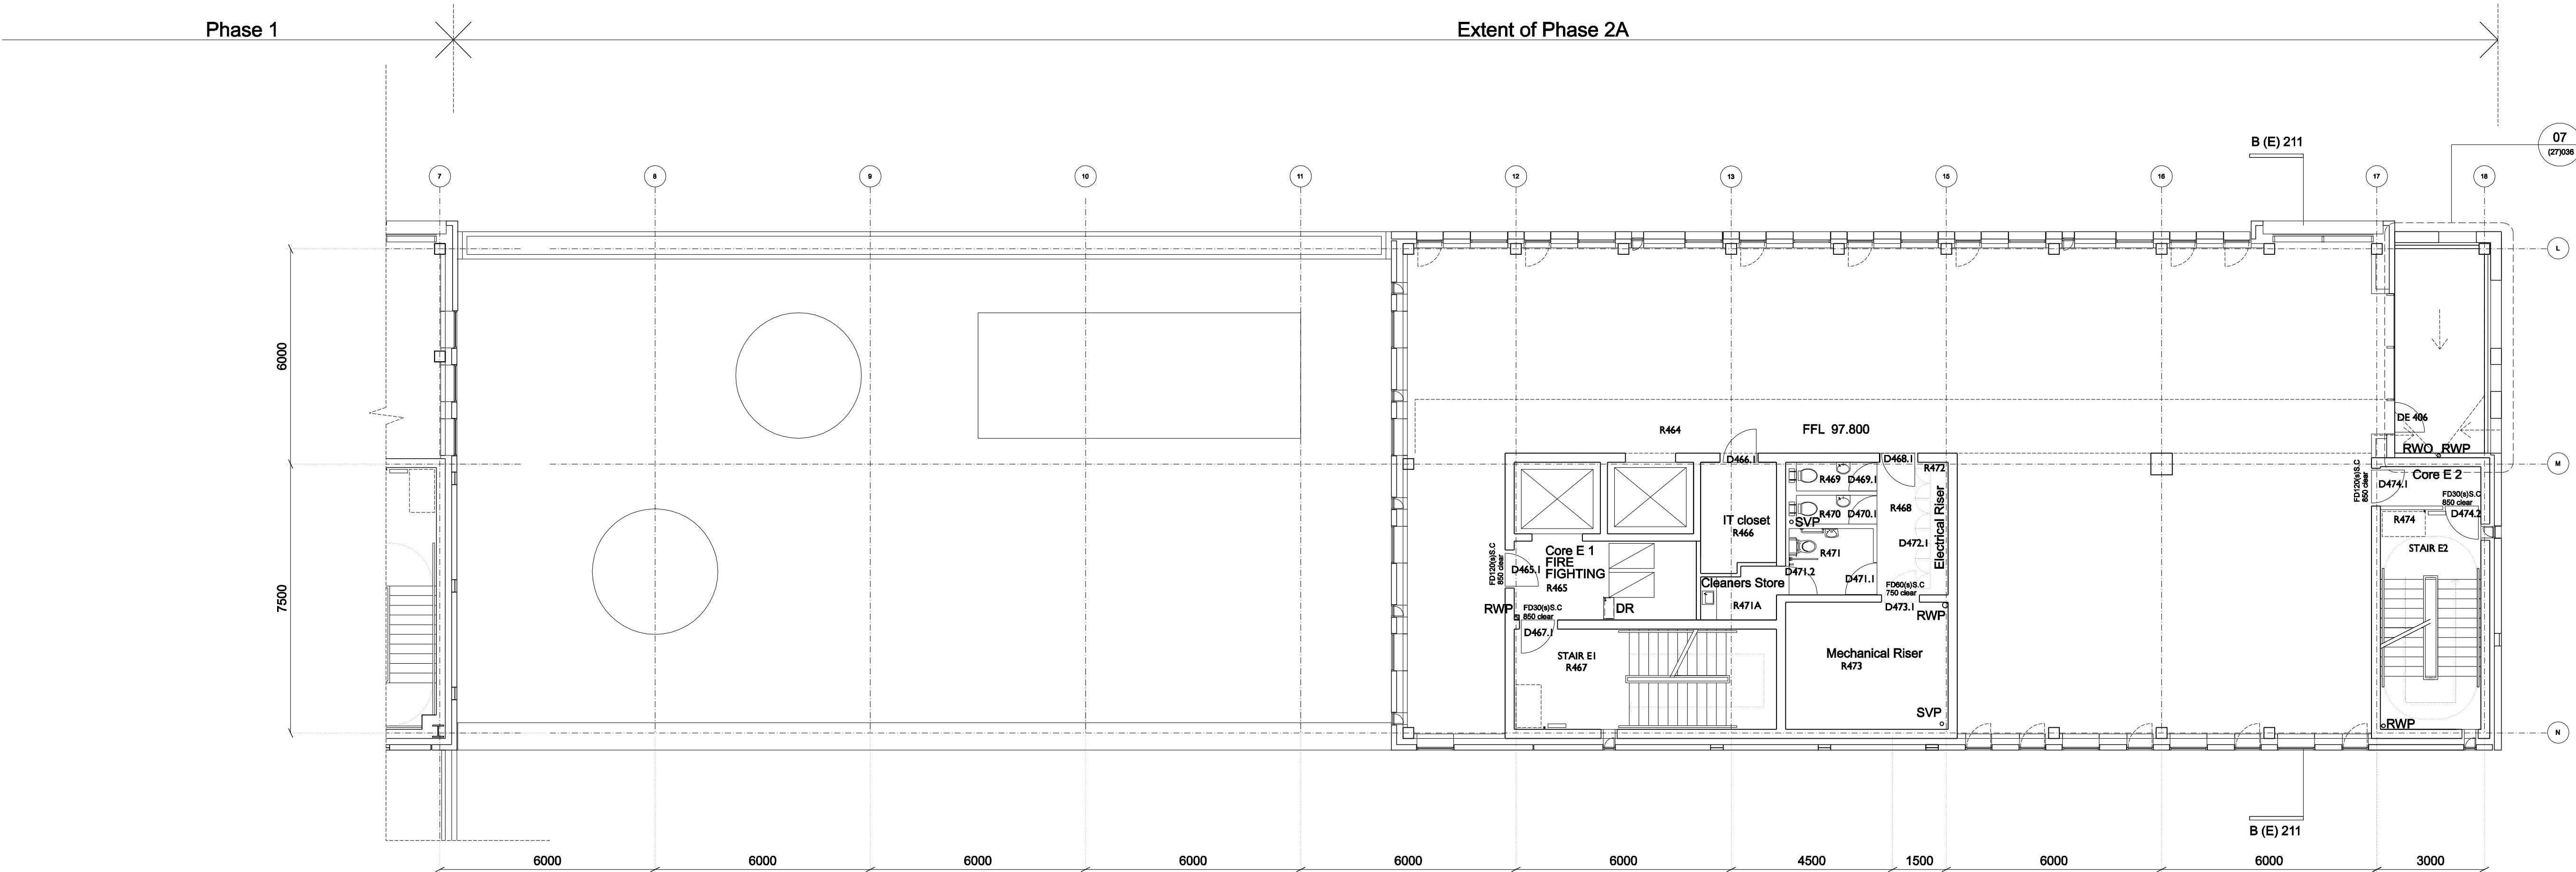

FFL 97.800

Revisions

- issued 19.11.04
A 26.11.04
B 06.01.05
C 18.02.05
D 18.03.05

Notes

B First billing issue (roofing)
Roof section and detail refs added
SVPs noted at roof level
Planters revised
Core E1 wall grid 13 realigned
D- Billing issue (roofing)
Further roofing notes added
Cleaners cupboard added to core E1
Tender Issue

Roofing Notes
-----> Direction of fall of roof membrane
RWO Rainwater outlet
RWP Rainwater downpipe
OF Rainwater overflow
SVP Soil vent pipe

**Bennetts Associates
with
Reiach and Hall
Architects**

Bennetts Associates Architects
□ 54 Manor Place Edinburgh EH3 7EH
□ Tel: +44 (0)131 225 9554
□ Fax: +44 (0)131 225 9379
□ E-mail: potterrow@bennettsassociates.com

Reiach and Hall Architects
□ 6 Darnaway Street Edinburgh EH3 6BG
□ Tel: +44 (0)131 225 8444
□ Fax: +44 (0)131 225 5079
□ E-mail: potterrow@reichandhall.co.uk

Project
**Potterrow Development
for University of Edinburgh**

Drawing Title
**Phase 2A
Fourth Floor Plan**

job no.	drawing no.	revision	status
0312	B(E)104	D	T

scale @ A3	scale @A1	date
1:200	1:100	Jan 05