


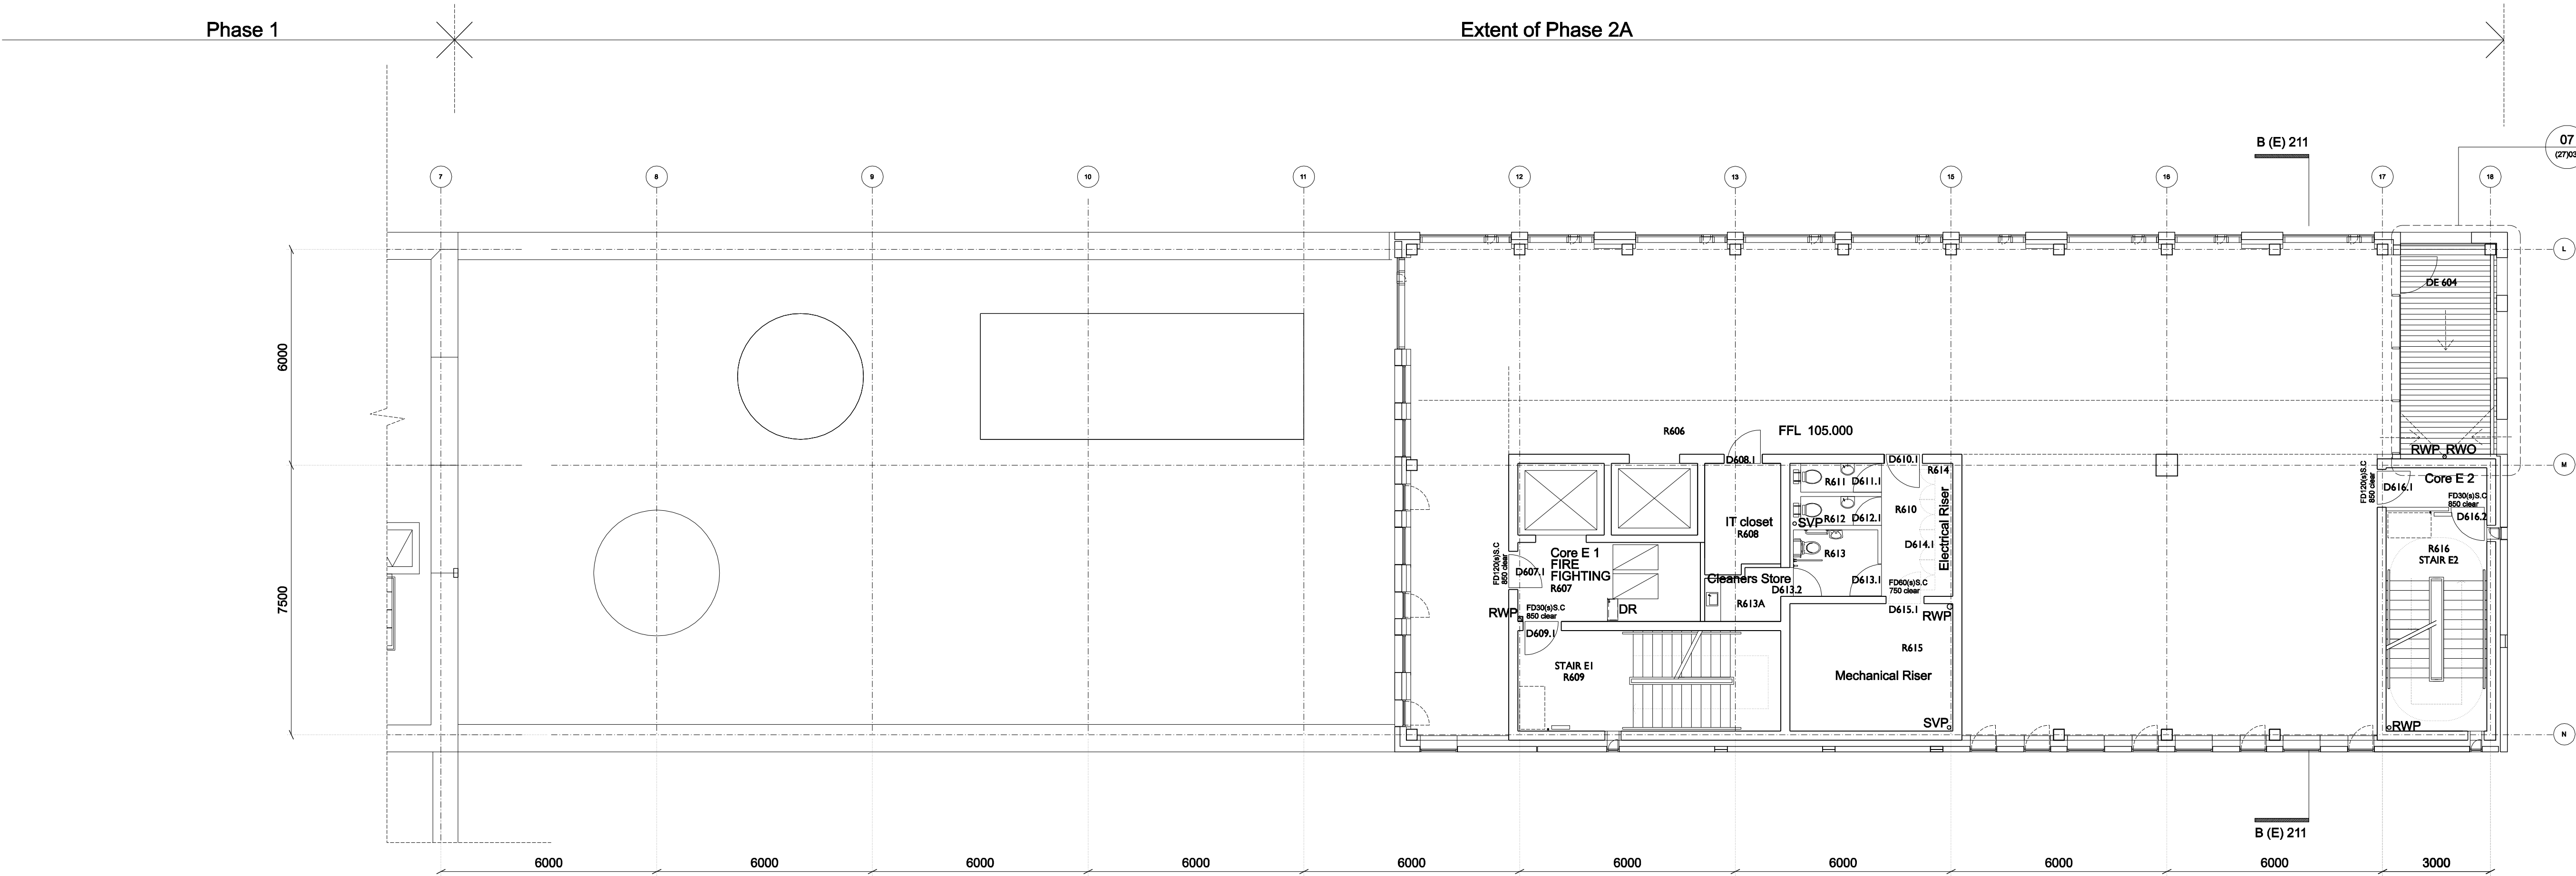

FFL 105.000

Revisions

- issued 19.11.04
C- 18.02.05
D- 18.03.05

Notes

C- Billing issue (roofing)
Further roofing notes added
Cleaners cupboard added to core E1
D Tender Issue

Roofing Notes

Direction of fall of roof membrane
RWO Rainwater outlet
RWP Rainwater downpipe
Rainwater overflow
SVP Soil vent pipe

**Bennetts Associates
with
Reiach and Hall
Architects**

Bennetts Associates Architects

54 Manor Place Edinburgh EH3 7EH
Tel: +44 (0)131 225 9554
Fax: +44 (0)131 225 9379
E-mail: potterrow@bennettsassociates.com

Reiach and Hall Architects

6 Darnaway Street Edinburgh EH3 6BG
Tel: +44 (0)131 225 8444
Fax: +44 (0)131 225 5079
E-mail: potterrow@reichandhall.co.uk

Project

**Potterrow Development
for University of Edinburgh**

Drawing Title

**Phase 2A
Sixth Floor Plan**

job no. 0312
drawing no. B(E)106
revision D
status T

scale @ A3 1:200
scale @ A1 1:100
date Jan 05